



City of Prince Albert

Service Connection Note

CIVIC ADDRESS _____ DATE _____

LOT _____ BLOCK _____ PLAN _____

SEWER SERVICE

PIPE: DIA. _____ TYPE _____ LENGTH _____

WATER SERVICE

PIPE: DIA. _____ TYPE _____ LENGTH _____

THAW WIRE: Y / N LENGTH _____

FITTING SIZES: CLAMP _____ CORP _____ CURB _____

SPECIALS _____


TRENCHING

LENGTHS: MACHINE _____ HAND _____ AUGER _____

OTHER _____

Service Connection Tie-in


SHOW LOCATION OF WATER AND SEWER SERVICES IN RELATION TO LOT PROPERTY LINES

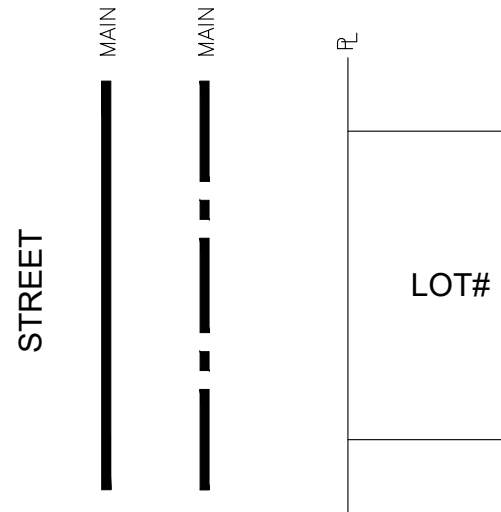

Service Connection Profile

ALL ELEVATIONS ARE TO BE IN GEODETIC FORMAT BASED ON THE CITY OF PRINCE ALBERT BENCHMARK INFORMATION

T/FINISHED GRADE @ RL
= _____

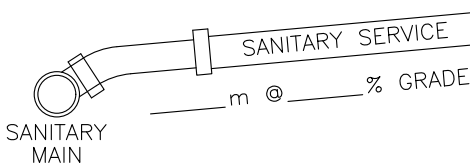


INVERT ELEVATION @ RL
= _____

NOTE: MINIMUM GRADE FOR 100mm SEWER PIPE IS 2.00%.
MINIMUM GRADE FOR 150mm SEWER PIPE IS 1.00%.

Lot Grading Plan

PROVIDE DIAGRAM OF TOP VIEW OF LOT INDICATING FINISHED GRADE AT EACH PROPERTY DEFLECTION POINT AND ELEVATION AT THE STAMPED CC

STREET

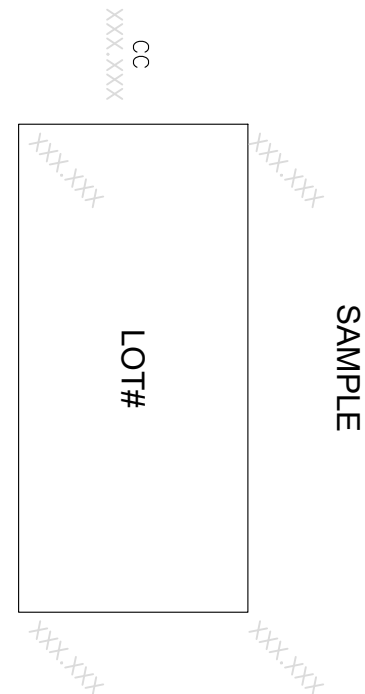

CITY OF PRINCE ALBERT
PUBLIC WORKS

APPROVED

Wes Hicks

SERVICE CONNECTION NOTE
RESIDENTIAL DEVELOPMENTS

SCALE N.T.S.

No. DATE REVISION

DRAWN S. NUMEDAHL | DESIGNED N. MILLER | DATE MAR. 2015

DWG. No. 00-01-20